
 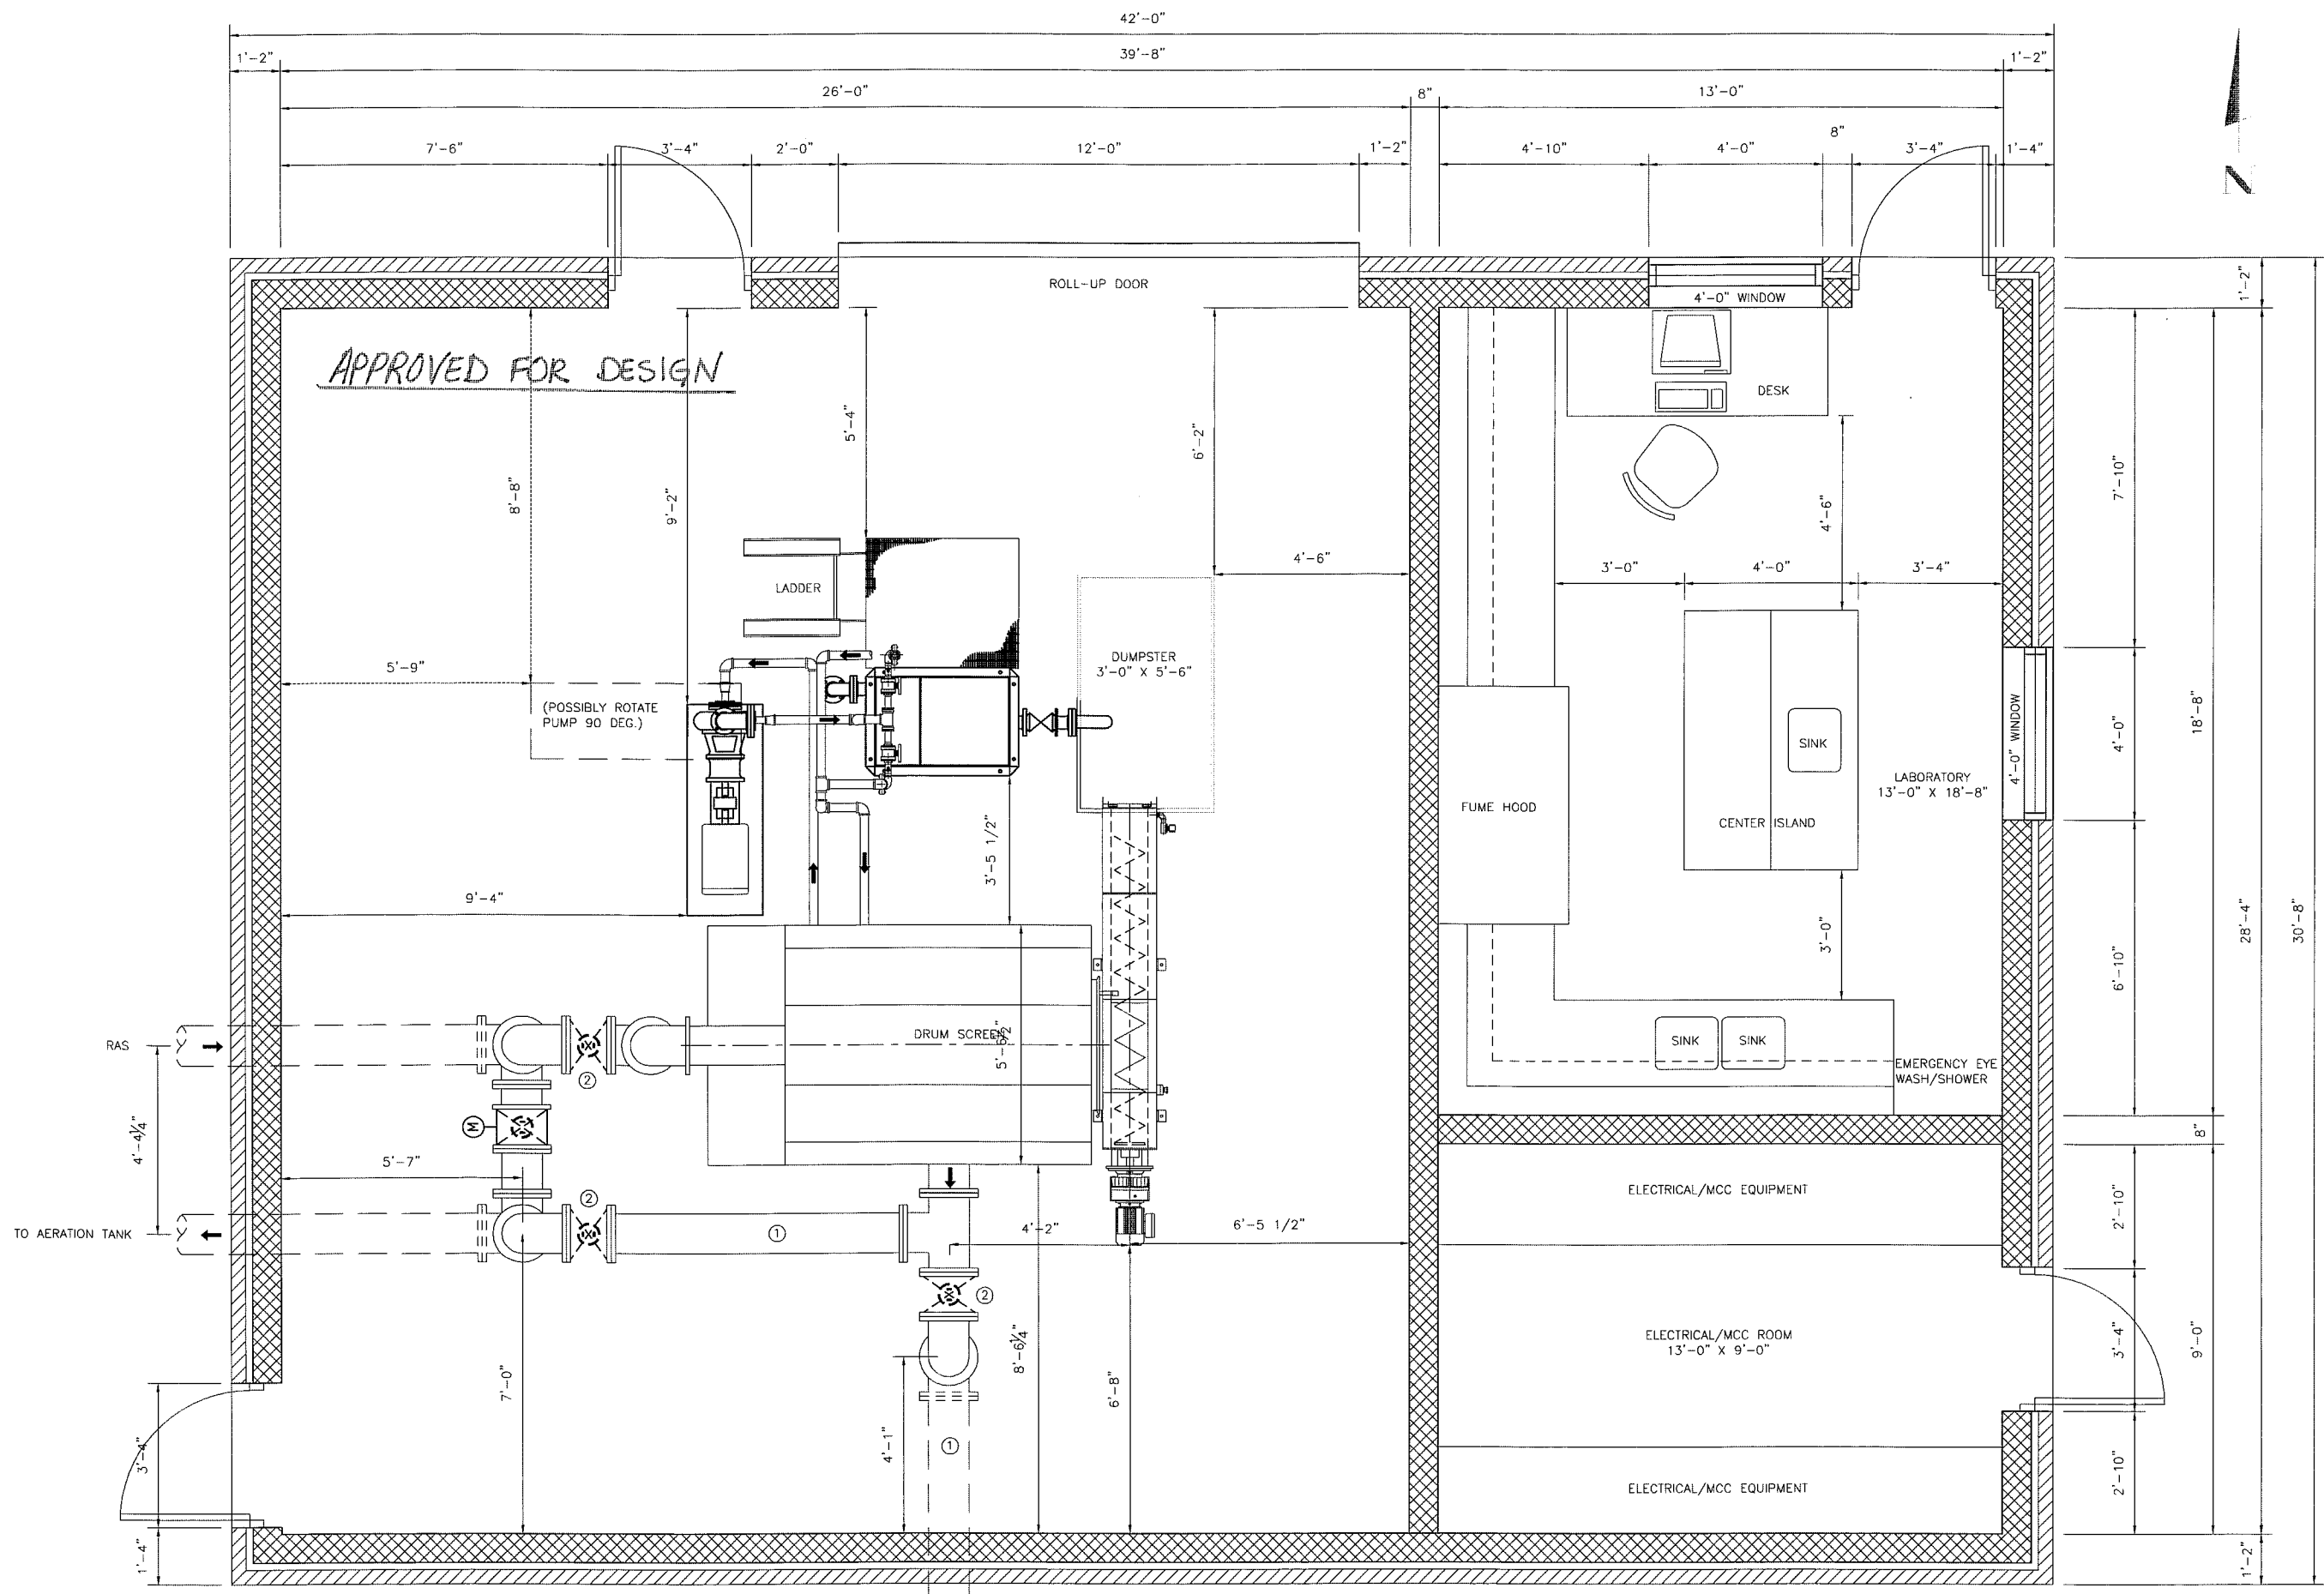


REVISIONS		
NUMBER	BY	DATE



LEGEND
 ① 10" D.I.P.
 ② PLUG VALVE

**CITY OF OREGON
 OREGON, ILLINOIS**

**WASTEWATER TREATMENT PLANT IMPROVEMENTS
 SOLID SEPARATION MODULE BUILDING
 PIPING PLAN**

© Copyright CMT, Inc.
CMT
 CRAWFORD, MURPHY & TILLY, INC.
 CONSULTING ENGINEERS
 License No. 184-000613

DESIGN BY: JW/CAD
 DRAWN BY: JW/CAD
 CHECKED BY:
 APPROVED BY:
 DATE: APRIL 2007
 JOB No: 03001-15-00